
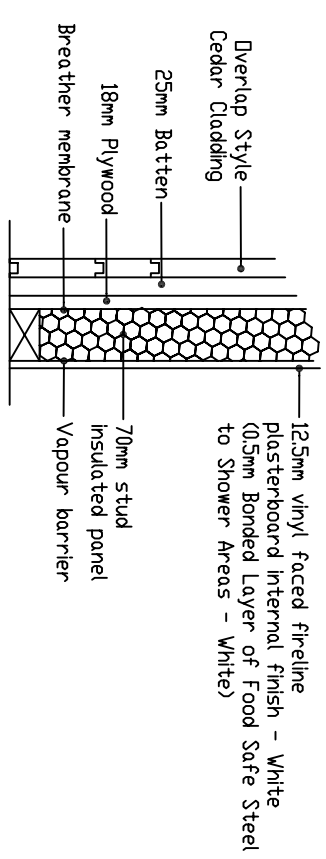


FOR APPROVAL


APPROVED BY: \_\_\_\_\_

DATE: \_\_\_\_\_

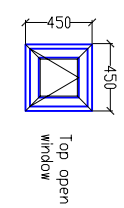

WINDOW DETAILS

WALL CONSTRUCTION

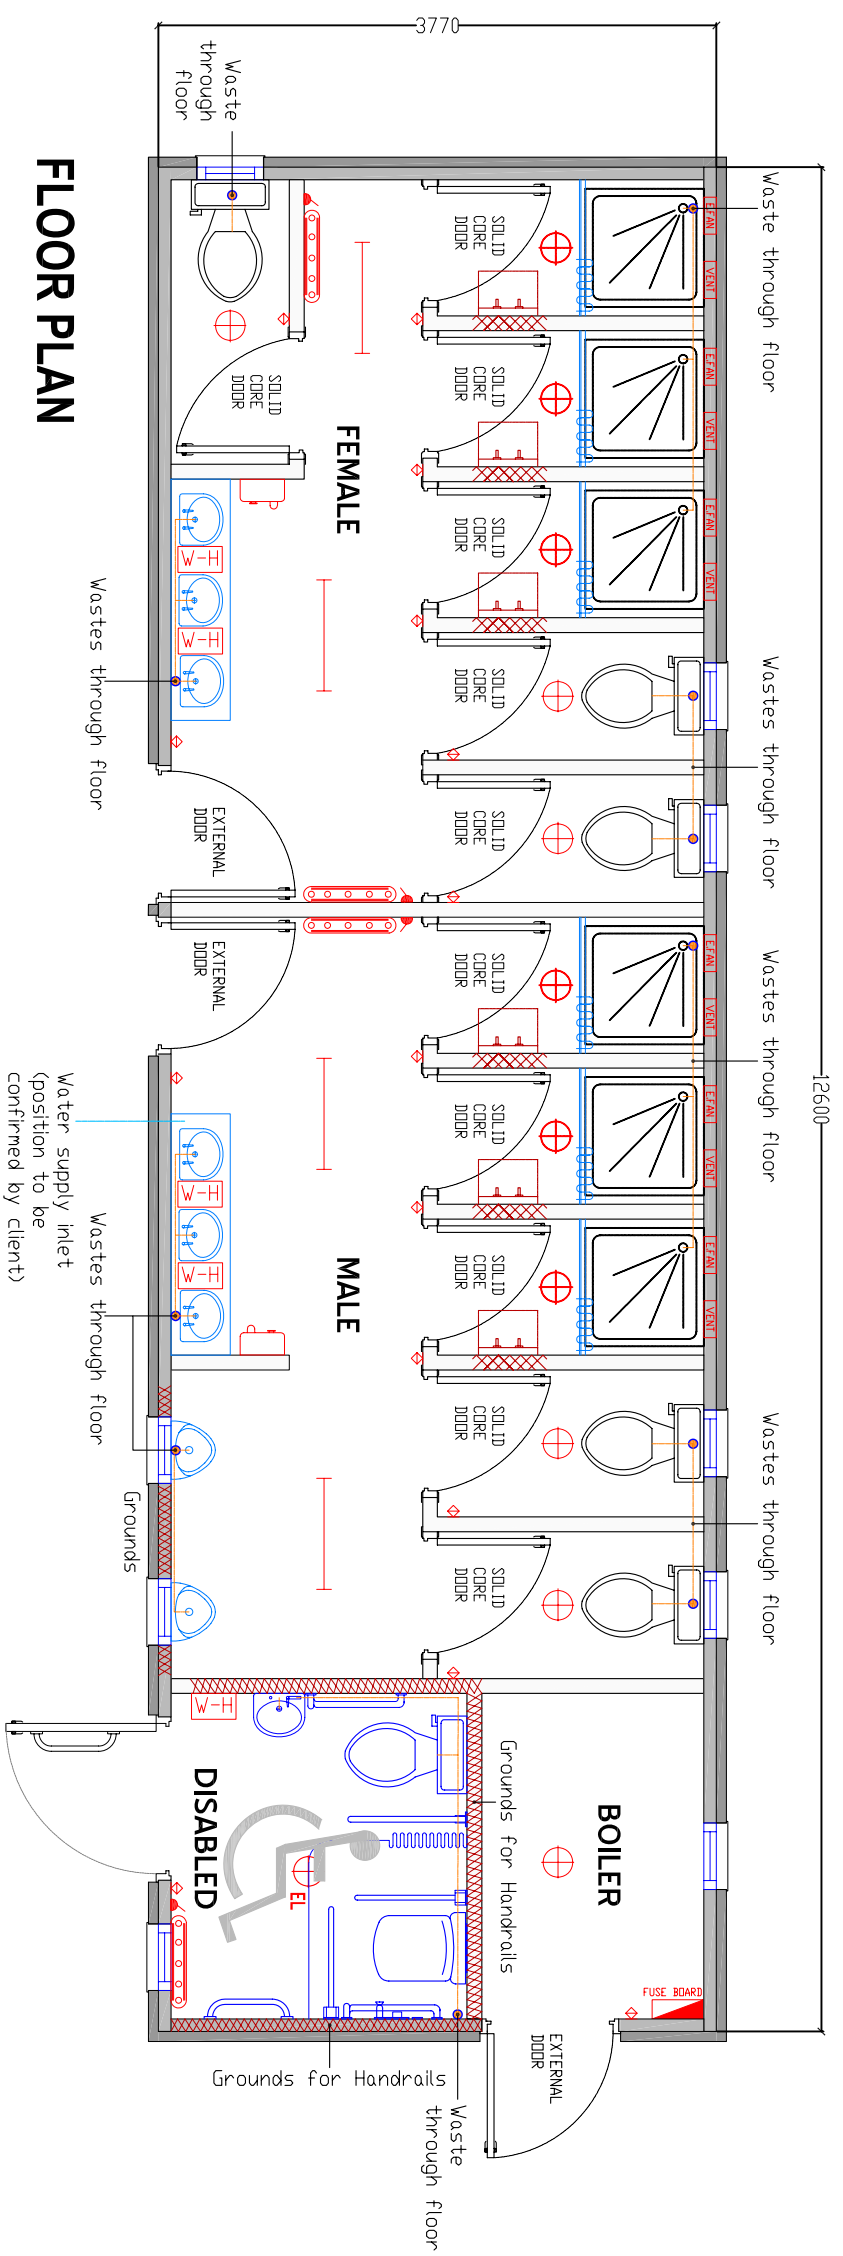

FLOOR PLAN

NOTES:

ELECTRICAL LEGEND

- 4ft SINGLE FLUORESCENT
- 2D LIGHT FITTING
- EMERGENCY LIGHT BATTERY PACK
- ONE WAY SWITCH
- MEB UK 3 PHASE FUSE BOARD
- TUBULAR HEATER
- FUSED SPUR
- UNDER-SINK WATER HEATER
- EXTRACT FAN
- AIR VENT
- HAND DRYER

**TFS**  
Toilets for Sale Ltd  
Blue Highway Bold

TFS, Unit 3, Freemantle Park Farm,  
Cottington Hill, Hannington RG26 5UD.

DRAWING NO:  
TFS 09-0016